

KEY PLAN



	1X18w Ceiling Light Point
	1x36W Wall Tube Light Pont
	5A Socket Outlet for Exhaust far
	5A Socket With SWitch
	5/5A Socket With SWitch
	15a Switch
	32a Switch for vehicle charging
	Exhaust Fan Point

MOUNTING HEIGHTS :

SL.NO.	DESCRIPTION	MOUNTING HEIGHT
01	DB	1800mm from FFL
02	Switches / Switch box	1200mm from FFL (Bottom of Switch plate)
03	Heater / Mixer Sockets (In Kitchen)	450mm Above Kitchen counter
04	Fridge Socket point	750mm from FFL
05	TV Socket point	800mm from FFL
06	AC Socket Point (For Split units) (In Bed rooms)	2300mm from FFL
07	Wall light point	2300mm from FFL

ELECTRICAL CONSULTANT	CCTV CONSULTANT
AUDIO CONSULTANT	LANDSCAPE CONSULTANT


CLIENT:

PROJECT

DRAWING TITLE

DRAWING NO.	SCALE
-------------	-------

DATE	DWG. BY:
	CHKD. BY:

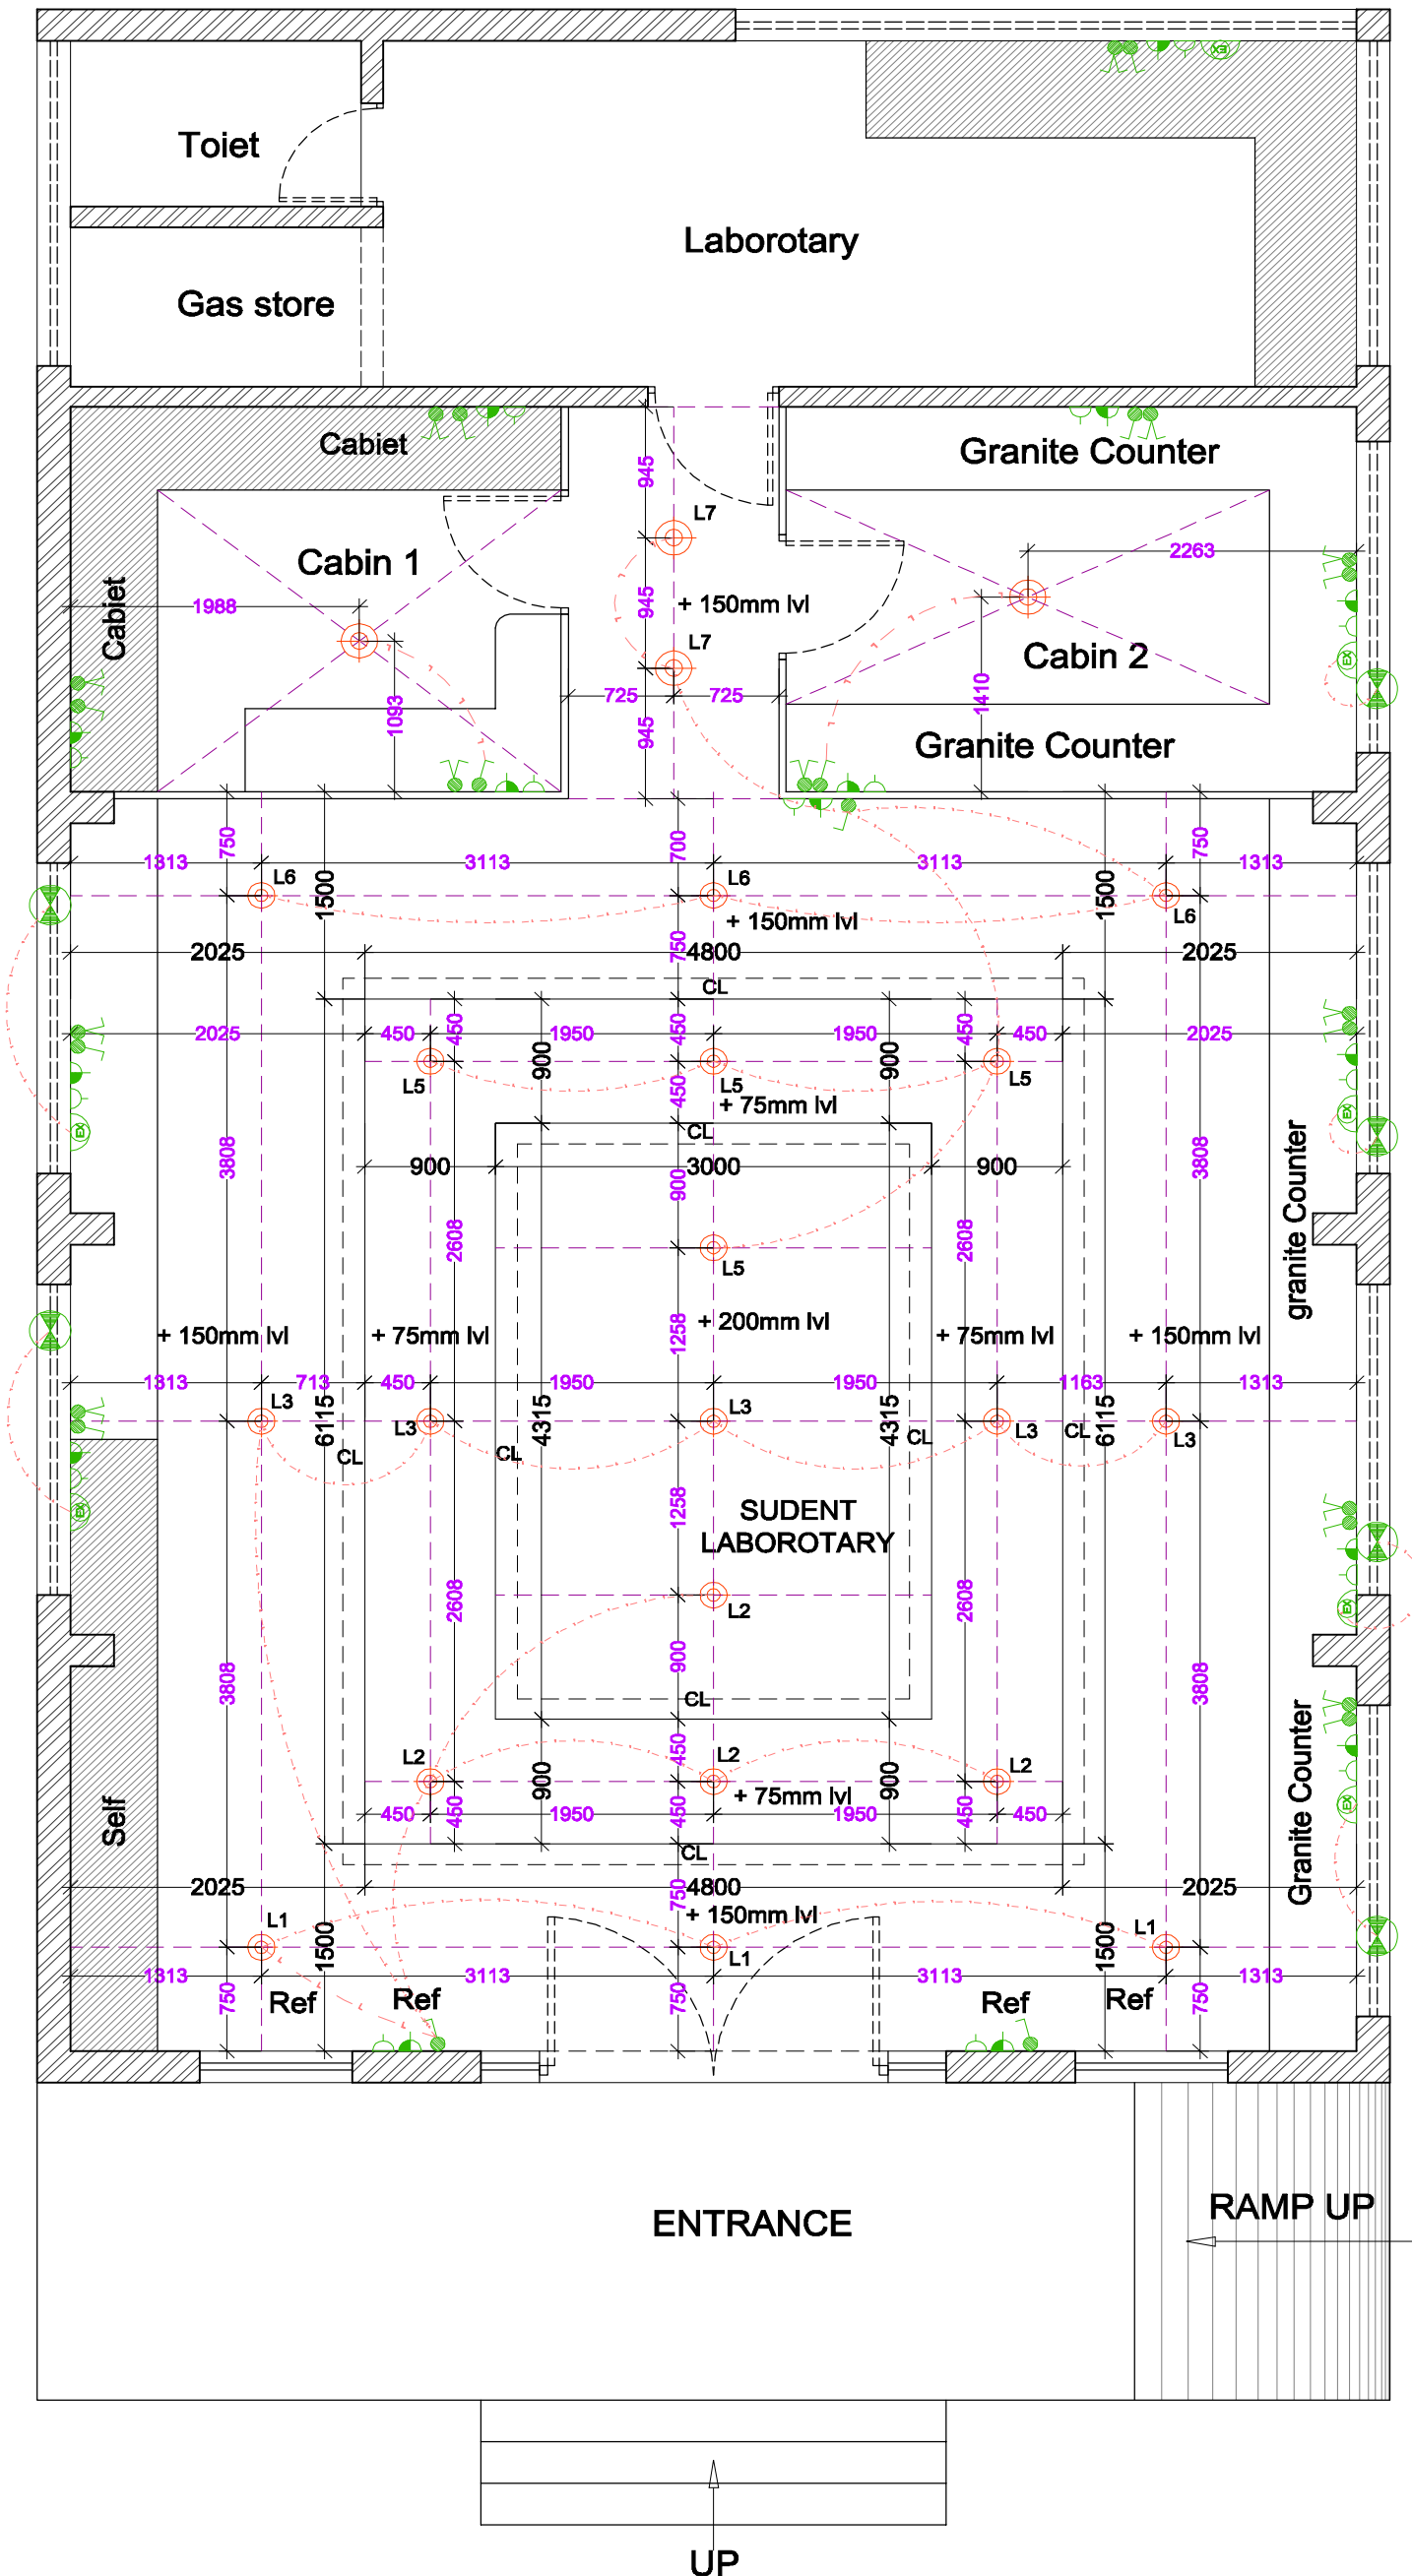

FALCEILING AND ELECTRICAL LAYOUT
PASHU PARIKSHANA BLOCK LABOROTARY